



GENERAL ELEVATION:

6201-6600 SHOWN, 6001-6200 ARE SIMILAR

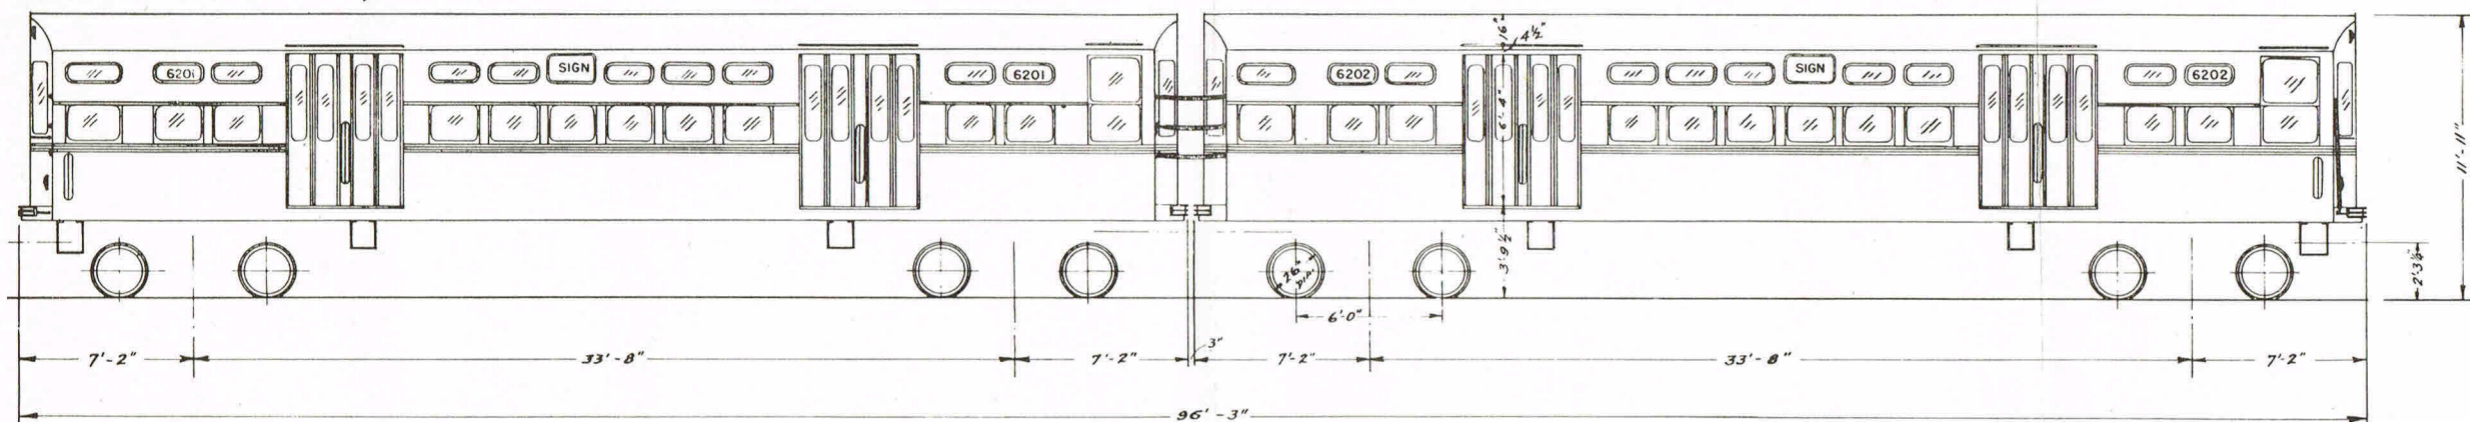

6131-6600


6001-6130

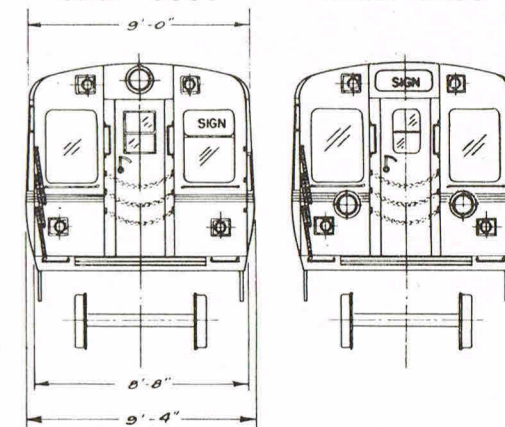


NO. 1 END

PLANS:

6001-6200 SHOWN, 6471-6600 ARE SIMILAR (See Note 3)

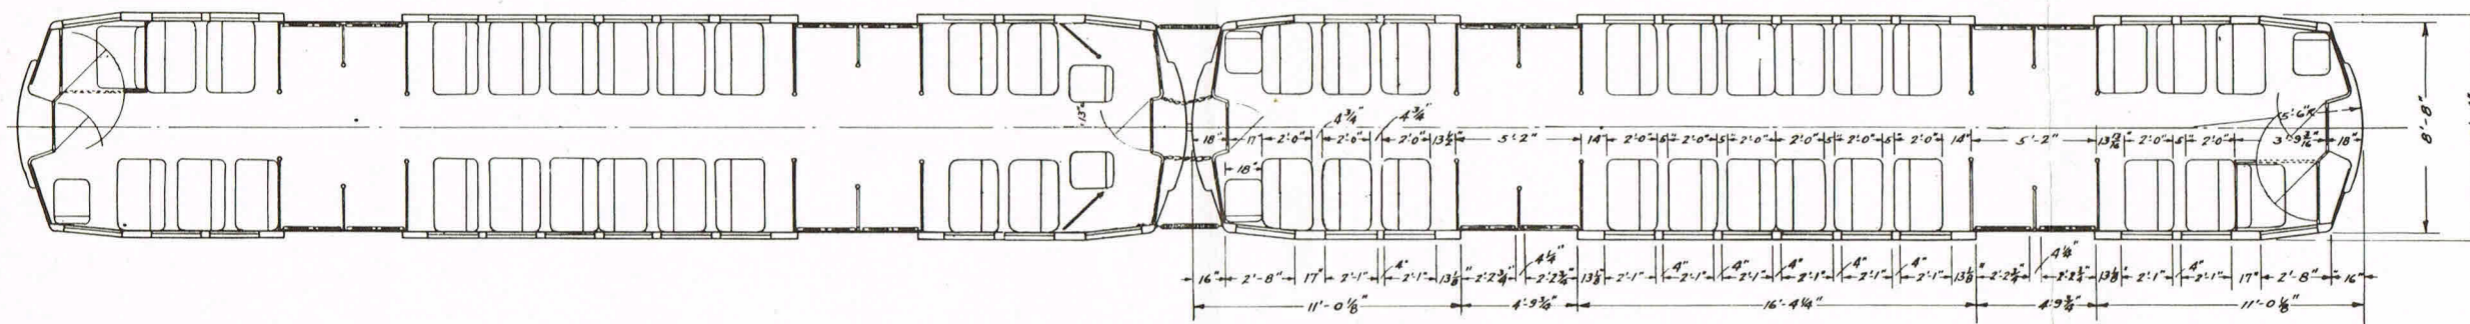

6201-6470

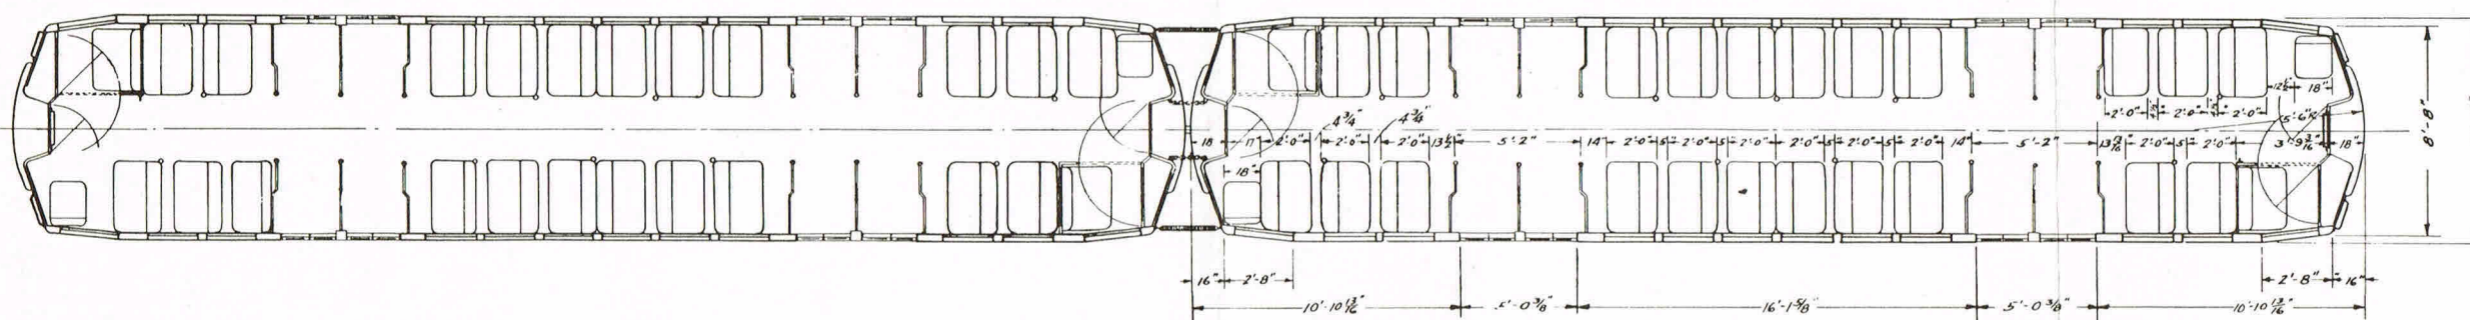

NOTES:

1. Cars 6123-6130 have trolley poles.
2. Cars 6127-6130 are equipped for high speed operation.
3. Cars 6471-6600 have seating arrangement similar to 6001-6200, but floor plan dimensions are similar to cars 6201-6470.

This drawing supersedes SEO-Y1151, Y2243, and Y3584.

CHICAGO TRANSIT AUTHORITY
STAFF ENGINEER'S OFFICE

6000 - CLASS
PERMANENTLY COUPLED
TWO-CAR UNITS

DRAWN 8-15-56 GM
SCALE 1/8" = 1'

CKD. *[Signature]*
APPR. *[Signature]*

SEO-Y5214